


MP1 PITCH: 20 ARRAY PITCH: 20  
 AZIMUTH: 192 ARRAY AZIMUTH: 192  
 MATERIAL: Comp Shingle STORY: 2 Stories

REVISED

314004201


 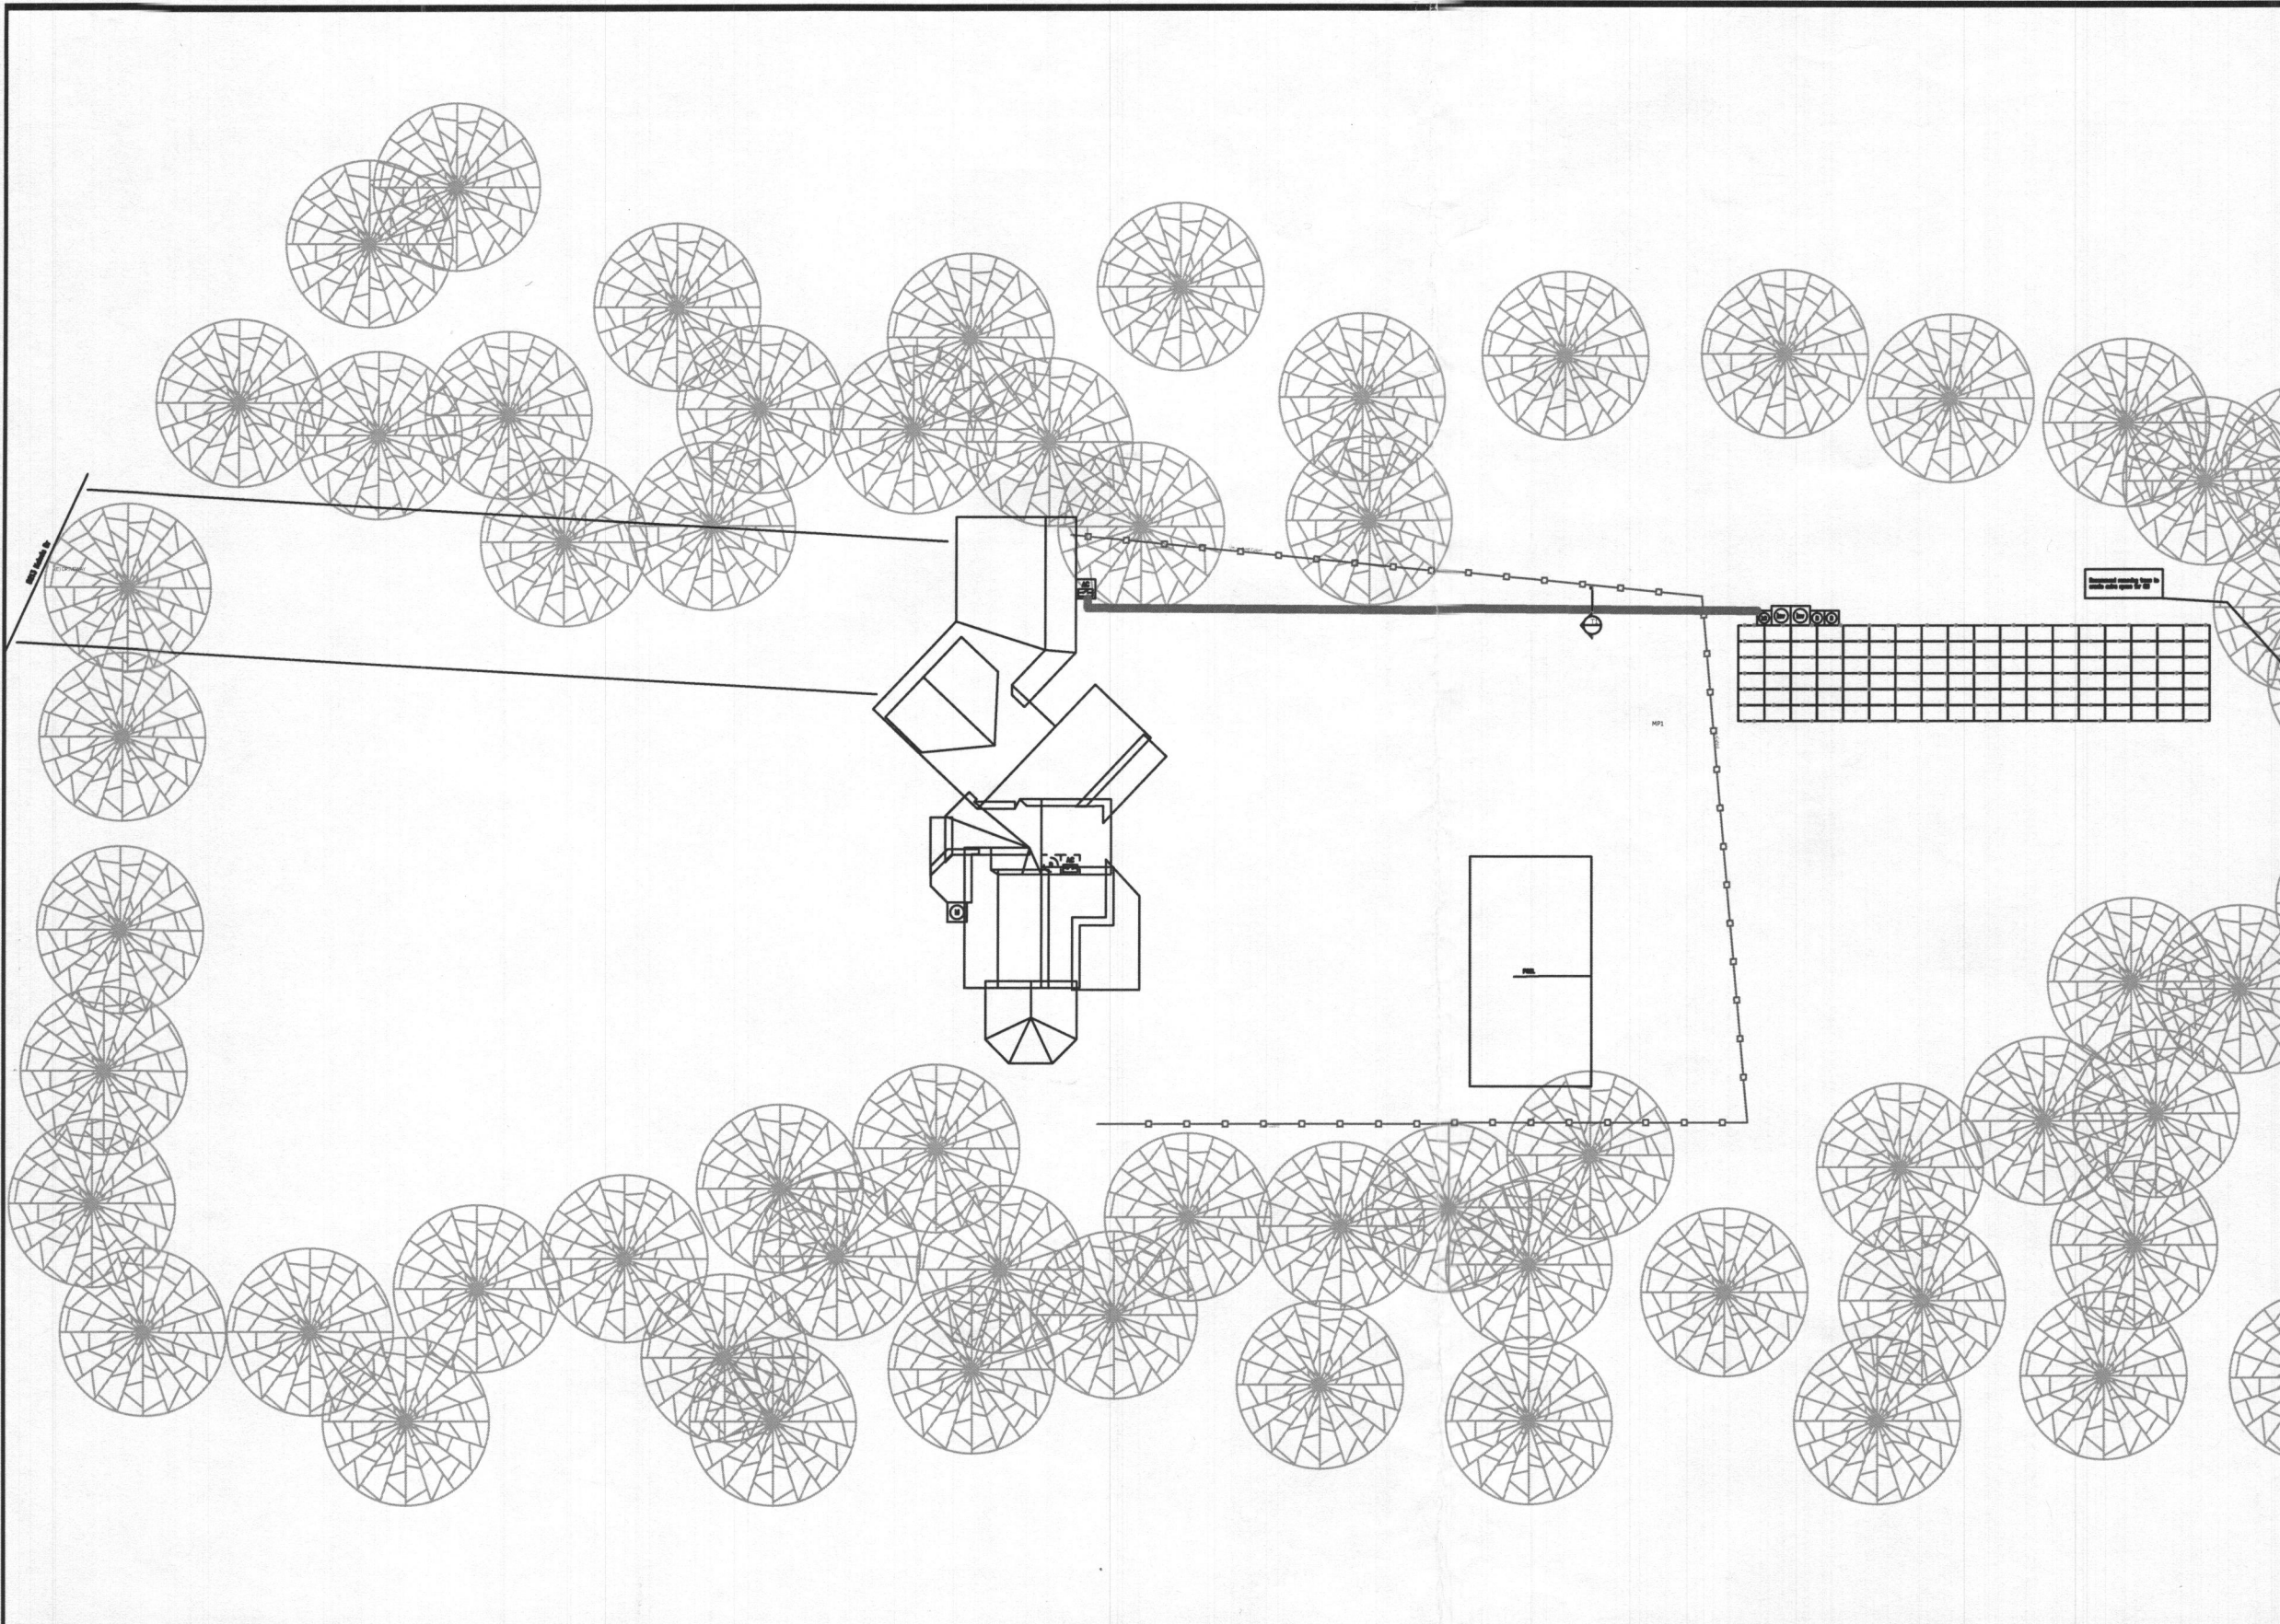


**LEGEND**

- (E) UTILITY METER & WARNING LABEL
- INVERTER W/ INTEGRATED DC DISCO & WARNING LABELS
- DC DISCONNECT & WARNING LABELS
- AC DISCONNECT & WARNING LABELS
- DC JUNCTION/COMBINER BOX & LABELS
- DISTRIBUTION PANEL & LABELS
- LOAD CENTER & WARNING LABELS
- DEDICATED PV SYSTEM METER
- STANDOFF LOCATIONS
- CONDUIT RUN ON EXTERIOR
- CONDUIT RUN ON INTERIOR
- GATE/FENCE
- HEAT PRODUCING VENTS ARE RED
- INTERIOR EQUIPMENT IS DASHED

**SITE PLAN**

Scale: 1/8" = 1'

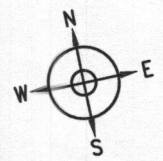

CONFIDENTIAL - THE INFORMATION HEREIN CONTAINED SHALL NOT BE USED FOR THE BENEFIT OF ANYONE EXCEPT SOLARCITY INC., NOR SHALL IT BE DISCLOSED IN WHOLE OR IN PART TO OTHERS OUTSIDE THE RECIPIENT'S ORGANIZATION, EXCEPT IN CONNECTION WITH THE SALE AND USE OF THE RESPECTIVE SOLARCITY EQUIPMENT, WITHOUT THE WRITTEN PERMISSION OF SOLARCITY INC.

JOB NUMBER: JB-210695 00  
 MOUNTING SYSTEM: Comp Mount Type C  
 MODULES: (108) YINGLI # YL250P-29b  
 INVERTER: FRONIUS # IG PLUS A 11.4

PREMISE OWNER:  
 AZOULAY, SAM  
 5213 KALMIA DR  
 DAYTON, MD 21036  
 (301) 455-9099

DESCRIPTION:  
 AZOULAY RESIDENCE  
 27 KW PV ARRAY  
 PAGE NAME:  
 SITE PLAN

DESIGN:  
 Mark Zacchilli  
 SHEET: PV 2 REV: 2 DATE: 12/8/2014

3055 Clearview Way  
 San Mateo, CA 94402  
 T: (650) 638-1028 F: (650) 638-1029  
 (888)-SOL-CITY (765-2489) www.solarcity.com