

PERMIT NUMBER: B 21002244

DATE ACCEPTED:

RECEIVED



RESIDENTIAL BUILDING PERMIT APPLICATION

HOWARD COUNTY DEPARTMENT OF INSPECTIONS, LICENSES, AND PERMITS
3430 COURT HOUSE DRIVE, ELLICOTT CITY, MD 21043 - PHONE: (410) 313-2455 OPTION #4
www.howardcountymd.gov

JUN 11 2021

LICENSES & PERMITS DIVISION

BUILDING SITE ADDRESS REQUIRED

Street Address: 13750 Lakeside Dr. Unit:
City: Clarksville State: MD Zip Code: 21029
Subdivision/Village/Complex Name: SDP/WP/BA #:
Lot: 9 Tax Map: 34 Grid 7 Parcel: 396 Grading Permit #:

DESCRIPTION OF WORK REQUIRED

Existing Use: Proposed Use: DECK Estimated Cost: \$15,000.00
Trade Work to Be Completed (Separate Permits Required): Mechanical (HVACR) Electrical Plumbing None
44x18 3 sets steps per plans

PROPERTY OWNER INFORMATION REQUIRED

Owner(s) Name(s) (As it appears on tax records): Adewale Adeleye Primary Residence: Yes No
Owner's Street Address: 13750 Lakeside Dr
City: Clarksville State: MD Zip Code: 21029
Phone: (301) 379-7575 Email: walebeauty@yahoo.com

APPLICANT NAME REQUIRED - INDIVIDUAL WHO SIGNS THIS APPLICATION

Business Name: Contact Name: Adewale Adeleye
Street Address: 13750 Lakeside Dr
City: Clarksville State: MD Zip Code: 21029
Phone: (301) 379-7575 Email: walebeauty@yahoo.com

CONTRACTOR INFORMATION REQUIRED

Business Name: Licensee's Name: License #:
Street Address:
City: State: Zip Code:
Phone: Email:

ARCHITECT/ENGINEER INFORMATION INDIVIDUAL WHO SIGNED PLANS, IF APPLICABLE

Business Name: Name:
Street Address:
City: State: Zip Code:
Phone: Email:

BUILDING CHARACTERISTICS REQUIRED

Primary Structure: SF Dwelling SF Townhouse SF Duplex Mobile Home Multi-Family Dwelling (MF\*) Condo: Yes No
Utilities: Electric Gas Water Supply: Public Private (Well) Sewage Disposal: Public Private (Septic)
Heating System: Electric Natural Gas Propane Other: Roadside Tree Project: No Yes: #
Sprinkler System: NFPA 13 NFPA 13R NFPA 13D None Fire Alarm System: Yes No Voice Evac

ADDITIONAL RESIDENTIAL INFORMATION (PLEASE SELECT/COMPLETE ALL THAT APPLY)

Model Name & Options:
# of Bedrooms (SF): # of efficiency units (MF\*): # of 1 BR (MF\*): # of 2 BR (MF\*): # of 3 BR (MF\*):
# Rooms: # Full Baths: # Half Baths: # Fireplaces:
Garage/Carport Info: Attached Garage Detached Garage Integral Garage Carport None
Basement/Foundation Info: Slab on Grade Post & Pier Unfinished Basement Finished Basement Full or Partial
1st Fl Width: 1st Fl Depth: 2nd Fl Width: 2nd Fl Depth: Bsmt Width: Bsmt Depth:
Energy Method: Prescriptive Performance UA Alternative ERI Gross Area: sq ft Occupiable Area: sq ft

AGREEMENT/ DISCALIMER REQUIRED

THE UNDERSIGNED HEREBY CERTIFIES AND AGREES AS FOLLOWS: (1) THAT HE/SHE IS AUTHORIZED TO MAKE THIS APPLICATION; (2) THAT THE INFORMATION IS CORRECT; (3) THAT HE/SHE WILL COMPLY WITH ALL REGULATIONS OF HOWARD COUNTY WHICH ARE APPLICABLE THERETO; (4) THAT HE/SHE WILL PERFORM NO WORK ON THE ABOVE REFERENCED PROPERTY NOT SPECIFICALLY DESCRIBED IN THIS APPLICATION; (5) THAT HE/SHE GRANTS COUNTY OFFICIALS THE RIGHT TO ENTER ONTO THIS PROPERTY FOR THE PURPOSE OF INSPECTING THE WORK PERMITTED AND POSTING NOTICES.


APPLICANT'S ORIGINAL SIGNATURE DATE SIGNED

FOR OFFICE USE ONLY CHECKS PAYABLE TO: DIRECTOR OF FINANCE OF HOWARD COUNTY

AGENCIES REQUIRED/APPROVALS:
PR DPZ DED Health SHA CID

SUBMITTAL FEES: \$50.00 PAYMENT: CK#1273\* ACCEPTED BY: DROPBOX

\* INCORRECT - \$50

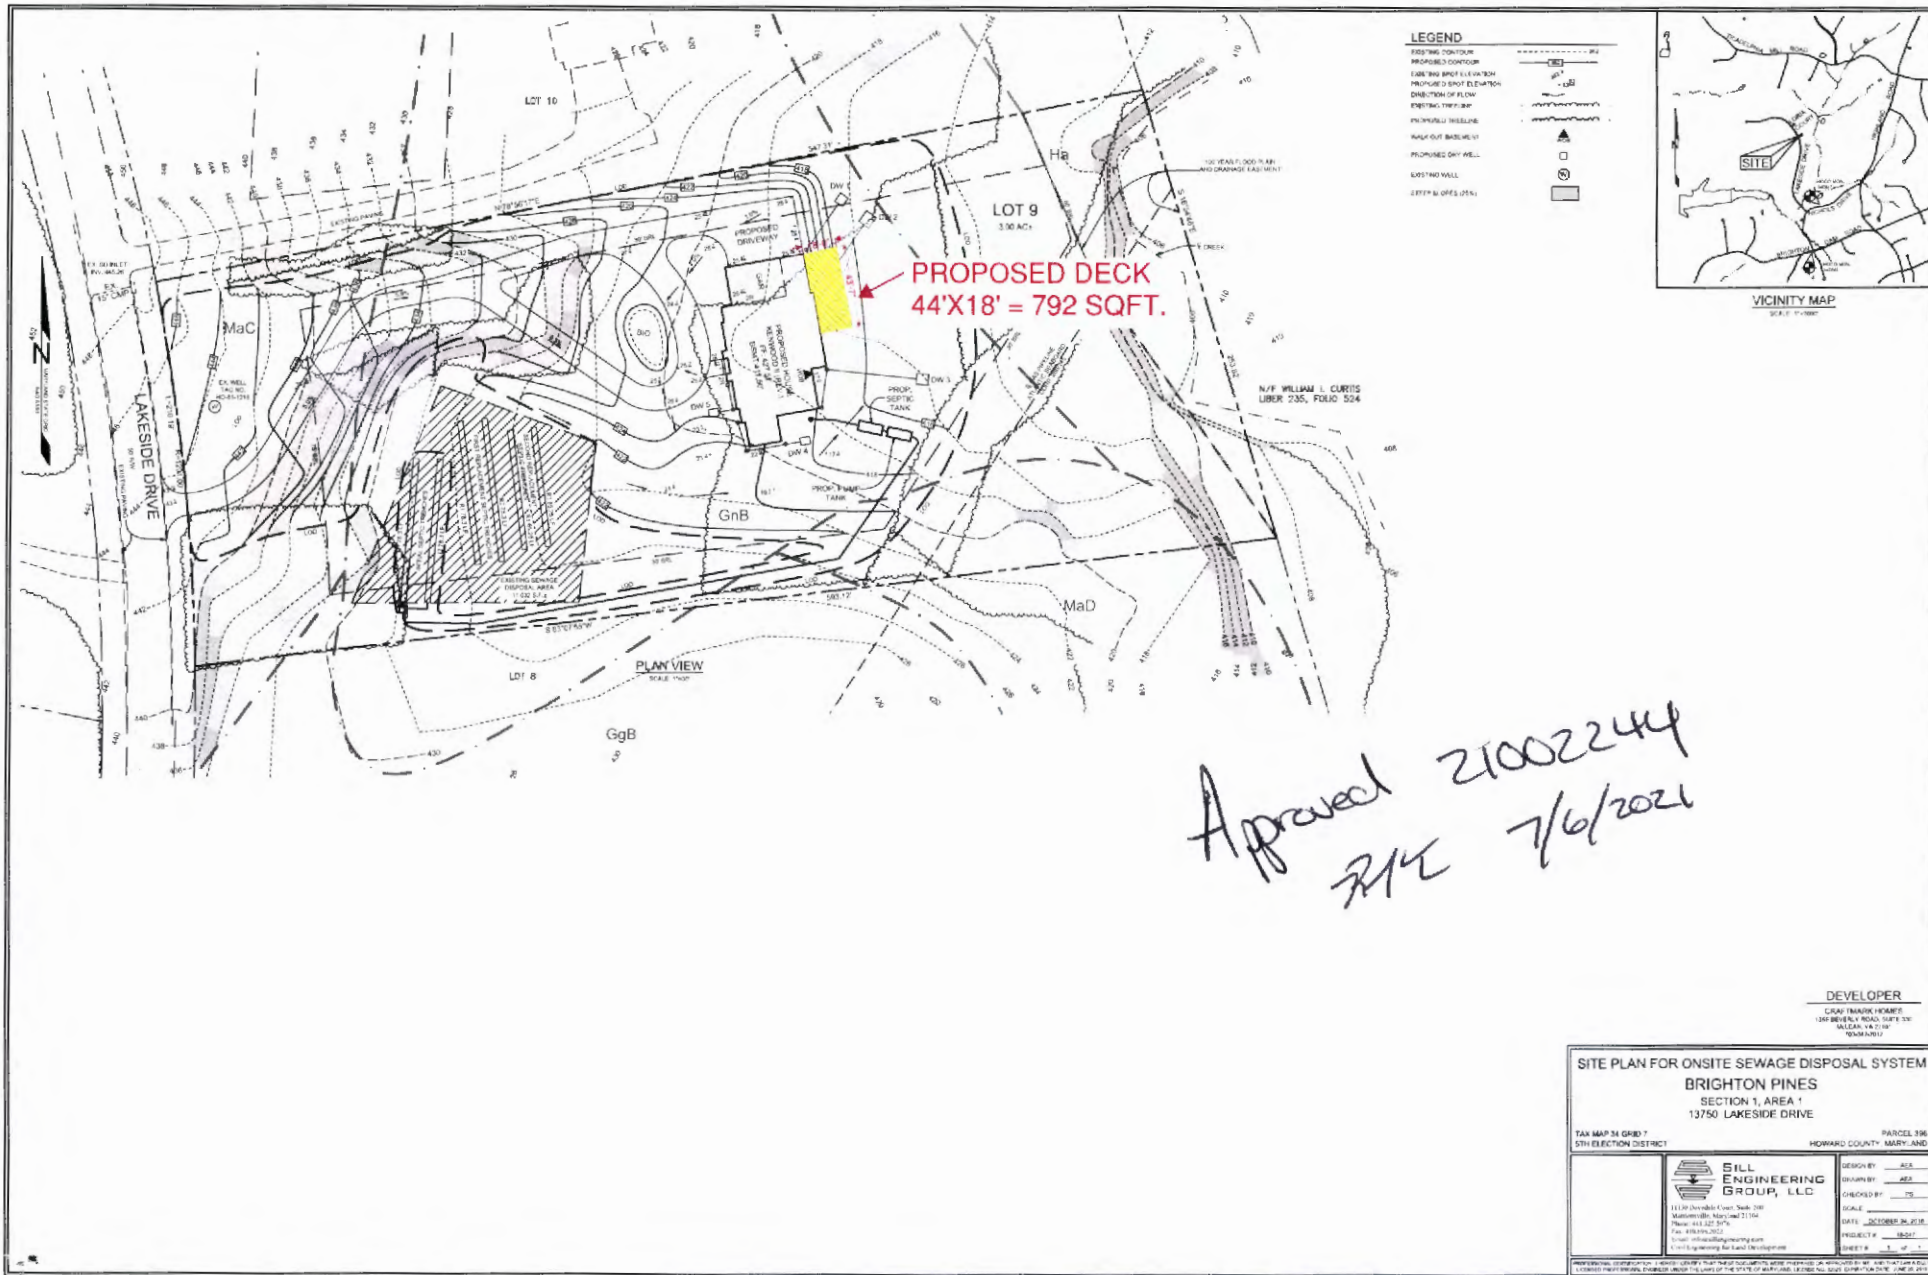

Approved 21002244  
R/K 7/6/2021

**DEVELOPER**

CREAT TRAKOR NUMBER  
100 BIRCHWOOD ROAD, SUITE 200  
MILFORD, VA 22641  
703-881-1111

**SITE PLAN FOR ONSITE SEWAGE DISPOSAL SYSTEM**  
**BRIGHTON PINES**  
SECTION 1, AREA 1  
13750 LAKESIDE DRIVE

TAX MAP 14 GRID 7 PARCEL 336  
5TH ELECTION DISTRICT HOWARD COUNTY, MARYLAND

<p><b>SILL ENGINEERING GROUP, LLC</b> 11100 University Court, Suite 200 Manassasville, Maryland 21104 Phone: 410.322.3474 Fax: 410.322.3472 Email: info@sillengineering.com www.sillengineering.com</p>	DESIGN BY: <u>ASL</u>
	DRAWN BY: <u>ASL</u>
	CHECKED BY: <u>TS</u>
	SCALE: _____
DATE: <u>OCTOBER 26, 2021</u>	PROJECT # <u>18021</u>
	SHEET # <u>1</u> OF <u>1</u>

PROFESSIONAL SEAL REQUIRED. THIS DOCUMENT IS THE PROPERTY OF SILL ENGINEERING GROUP, LLC. IT IS TO BE USED ONLY FOR THE PROJECT AND SITE SPECIFICALLY IDENTIFIED HEREIN. ANY REUSE OR MODIFICATION OF THIS DOCUMENT WITHOUT THE WRITTEN CONSENT OF SILL ENGINEERING GROUP, LLC IS STRICTLY PROHIBITED.